


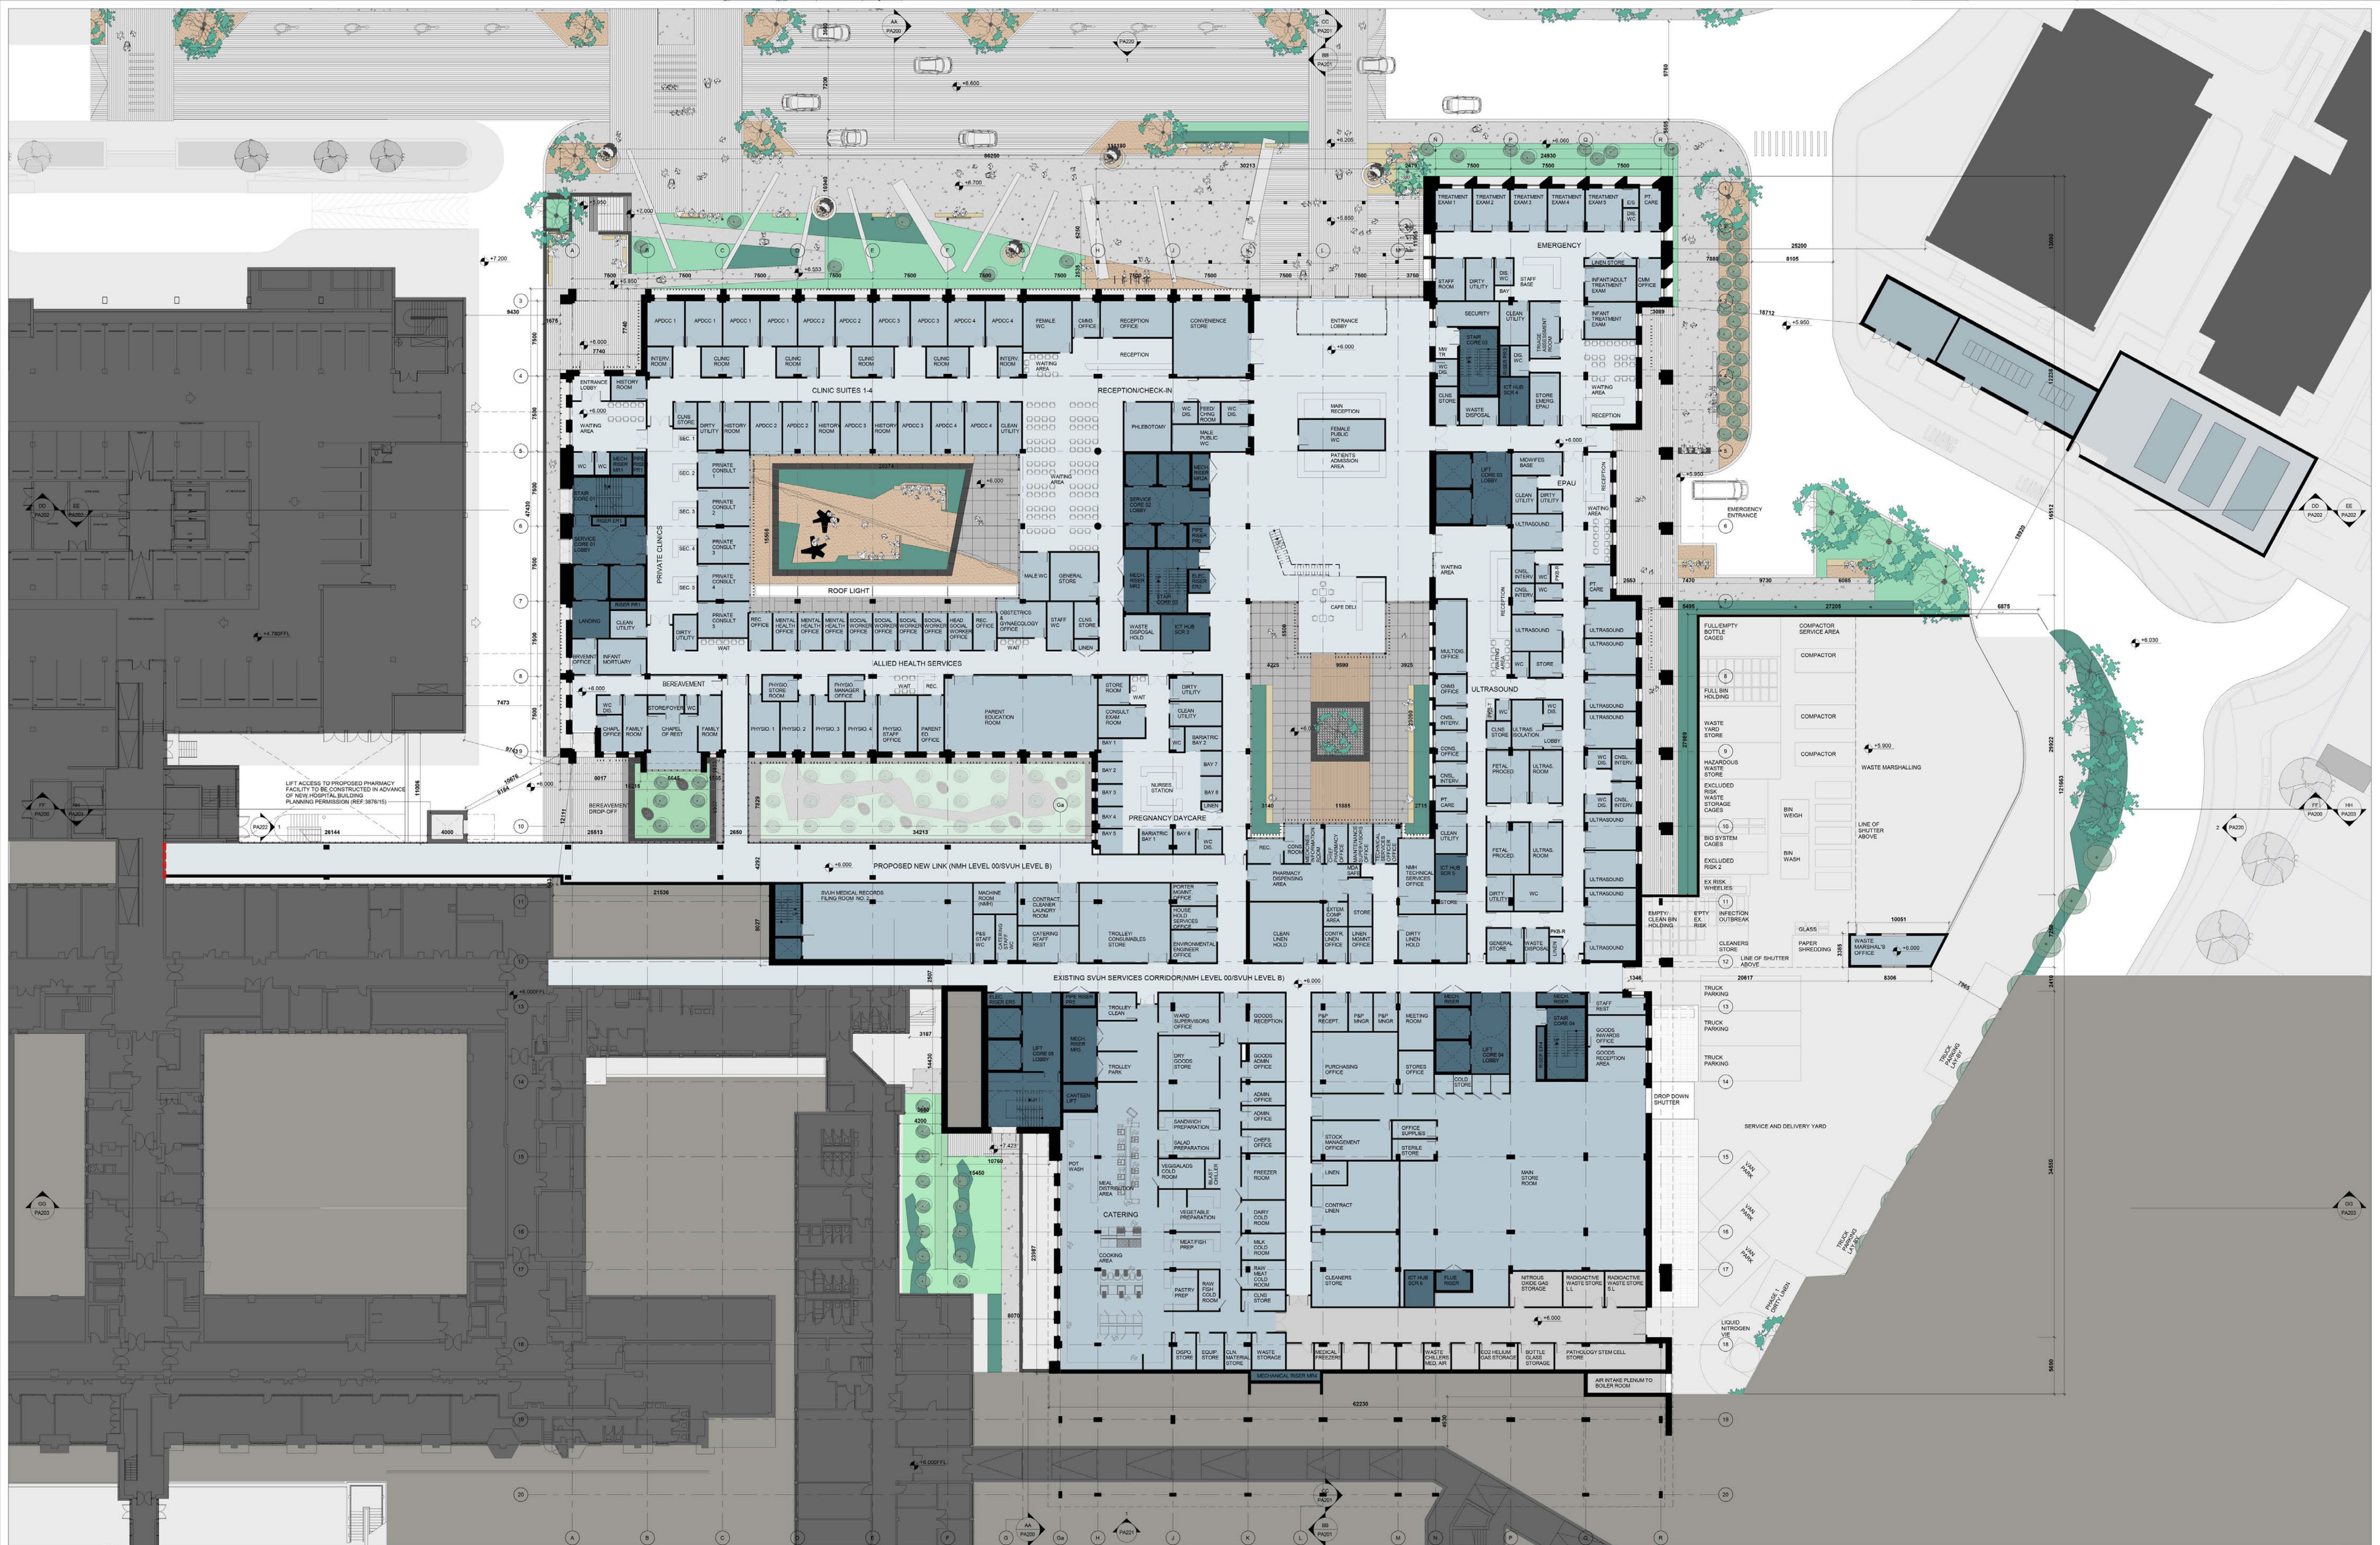

NOTES / LEGEND

GENERAL NOTES

- DO NOT SCALE. USE FIGURED DIMENSIONS ONLY.
- THIS DRAWING IS TO BE READ IN CONJUNCTION WITH ALL RELEVANT SPECIFICATIONS AND DRAWINGS.
- ALL DIMENSIONS TO BE CHECKED ON SITE.
- IN THE EVENT OF ANY DISCREPANCIES BETWEEN DRAWINGS, THE CONTRACTOR IS TO FOLLOW THE ARCHITECT'S IMMEDIATELY.

© O'CONNELL MAHON ARCHITECTS

EXISTING STRUCTURES TO BE REMOVED

Visual Scale 1:200 @ A0

Dimensions are in millimeters unless stated otherwise.

REVISION	DATE	DESCRIPTION	BY

PROJECT
THE NATIONAL MATERNITY HOSPITAL
AT ST. VINCENT'S UNIVERSITY HOSPITAL

CLIENT
HSE

BLOCK A+F LEVEL 0 FLOOR PLAN

PLANNING APPLICATION

DRAWING NUMBER
NMH_OCM_A_DR_PA_111

DATE
FEB 2017

DESIGNED BY
SM

PROJECT NUMBER
3895

9 Fitzwilliam Place
Dublin 2, Ireland

1 Lower Crescent
Belfast BT7 1NR

1 +353 1 676 7408
1 +353 1 676 5634

info@oconnellmahon.ie
www.oconnellmahon.ie

architects@isherwood-ellis.com