


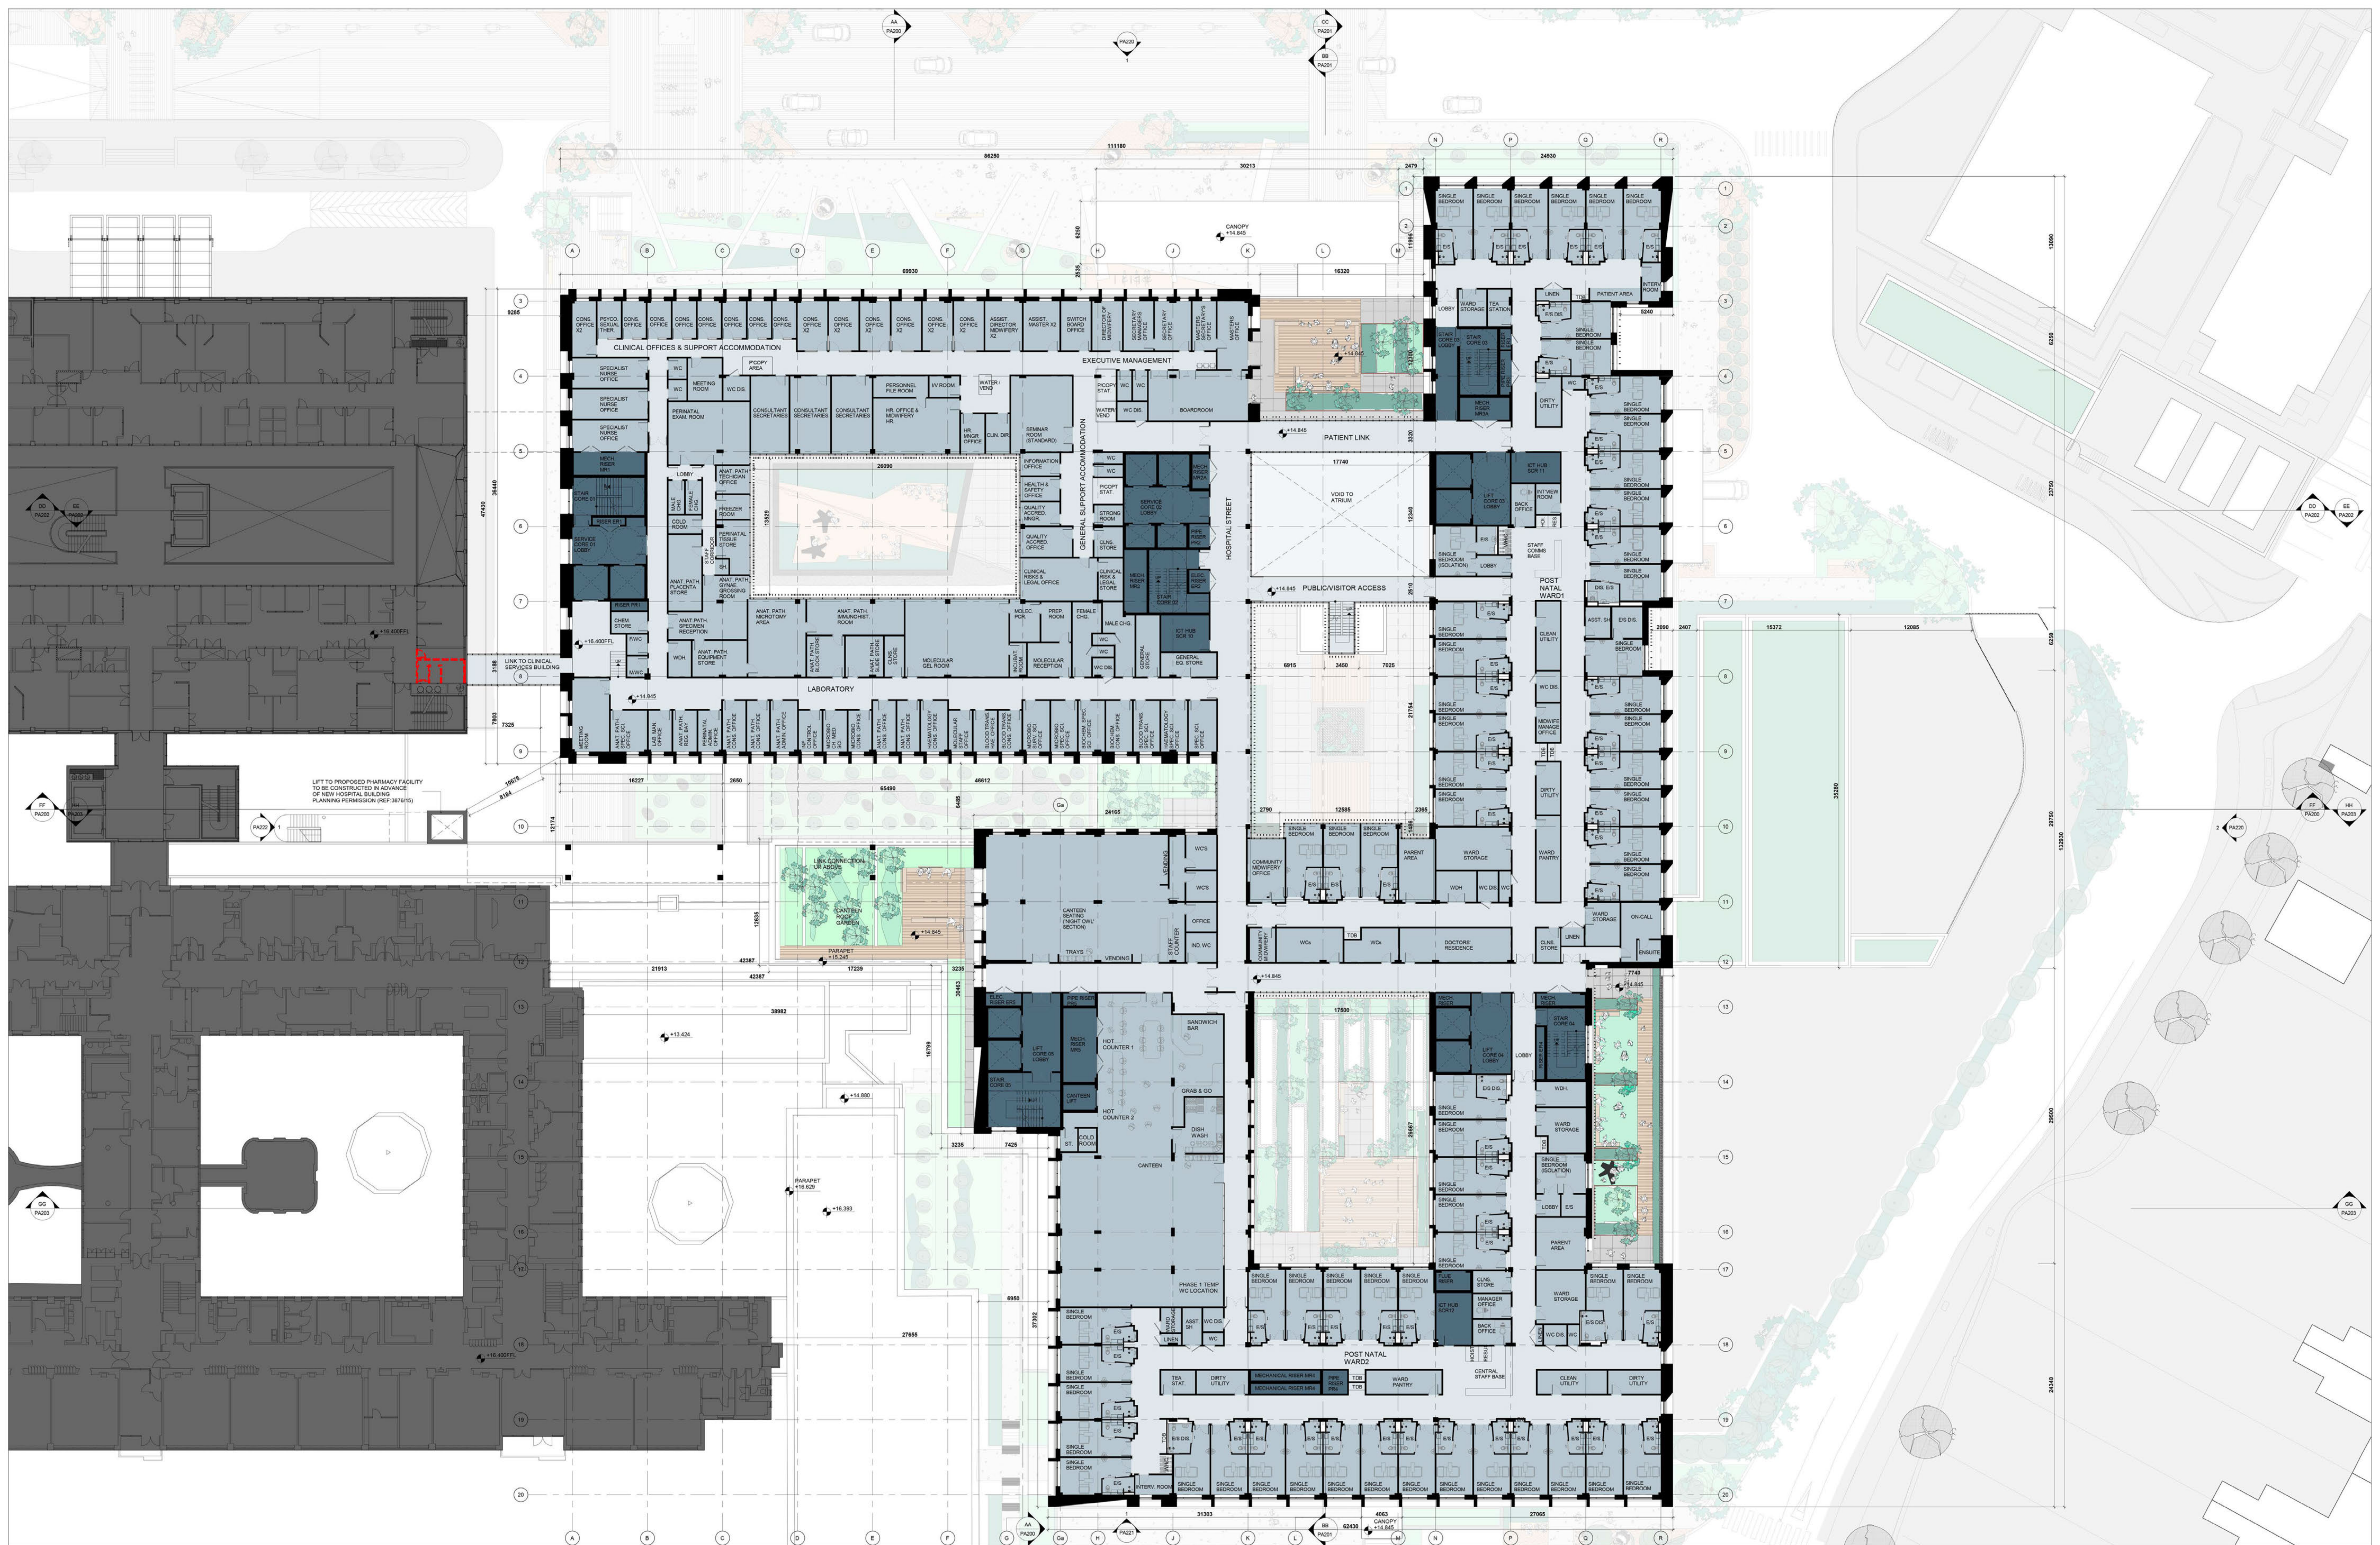

NOTES / LEGEND

GENERAL NOTES

- DO NOT SCALE: USE DIMENSIONS ONLY
- THIS DRAWING IS TO BE READ IN CONJUNCTION WITH ALL RELEVANT SPECIFICATIONS AND DRAWINGS
- ALL DIMENSIONS TO BE CHECKED ON SITE
- IN THE EVENT OF ANY DISCREPANCIES BETWEEN DRAWINGS, THE CONTRACTOR IS TO FOLLOW THE ARCHITECT IMMEDIATELY

0m 6m 9m 12m 15m 20m

VISUAL SCALE 1:200 @ A0

DIMENSIONS IN MILLIMETERS
LEVELS IN METERS

EXISTING STRUCTURES TO BE REMOVED

REVISION	DATE	DESCRIPTION	BY

PROJECT

THE NATIONAL MATERNITY HOSPITAL
AT ST. VINCENT'S UNIVERSITY HOSPITAL

CLIENT

HSE

DRAWING TITLE

BLOCK A+F LEVEL +2 FLOOR PLAN

ISSUE

PLANNING APPLICATION

DRAWING NUMBER

NMH_OCM_A_DR_PA_113

SCALE 1:200

DATE

FEB 2017

DRAWN BY

SM

CHECKED BY

SM

PROJECT NUMBER

3895

9 Fitzwilliam Place
Dublin 2, Ireland

1 Lower Crescent
Belfast BT1 1NR

1 +353 1 676 7408
1 +353 1 676 5634

info@oconnellmahon.ie
www.oconnellmahon.ie

architects@isherwood-ellis.com